

APPROVED: *[Signature]* DATE: 10-26-98
 SIMPSON HCP2

PERMIT APPROVAL IS CONDITIONED ON FULL COMPLIANCE, WHEN FIELD INSPECTED WITH ALL PROVISIONS OF THE CODES OF THE TOWN OF LONGBOAT KEY AND ALL OTHER APPLICABLE LAWS. ALL BUILDINGS, A/C, MECHANICAL, PLUMBING, ELECTRICAL AND FIRE INSTALLATIONS SHALL BE MADE BY LICENSED CONTRACTORS AND/OR RESIDENTIAL HOMEOWNERS.

BLDG:
 PLUMBING:
 ROOF:



ELC:
 MECH:
 ME:
 BP 15272
 SIMPSON HCP2
 TYP. @ CORNERS

FILE COPY

FRAMING PLAN

NOTES:
 1. ALL LUMBER TO BE P.T.

SCALE: 1/4" = 1'-0"

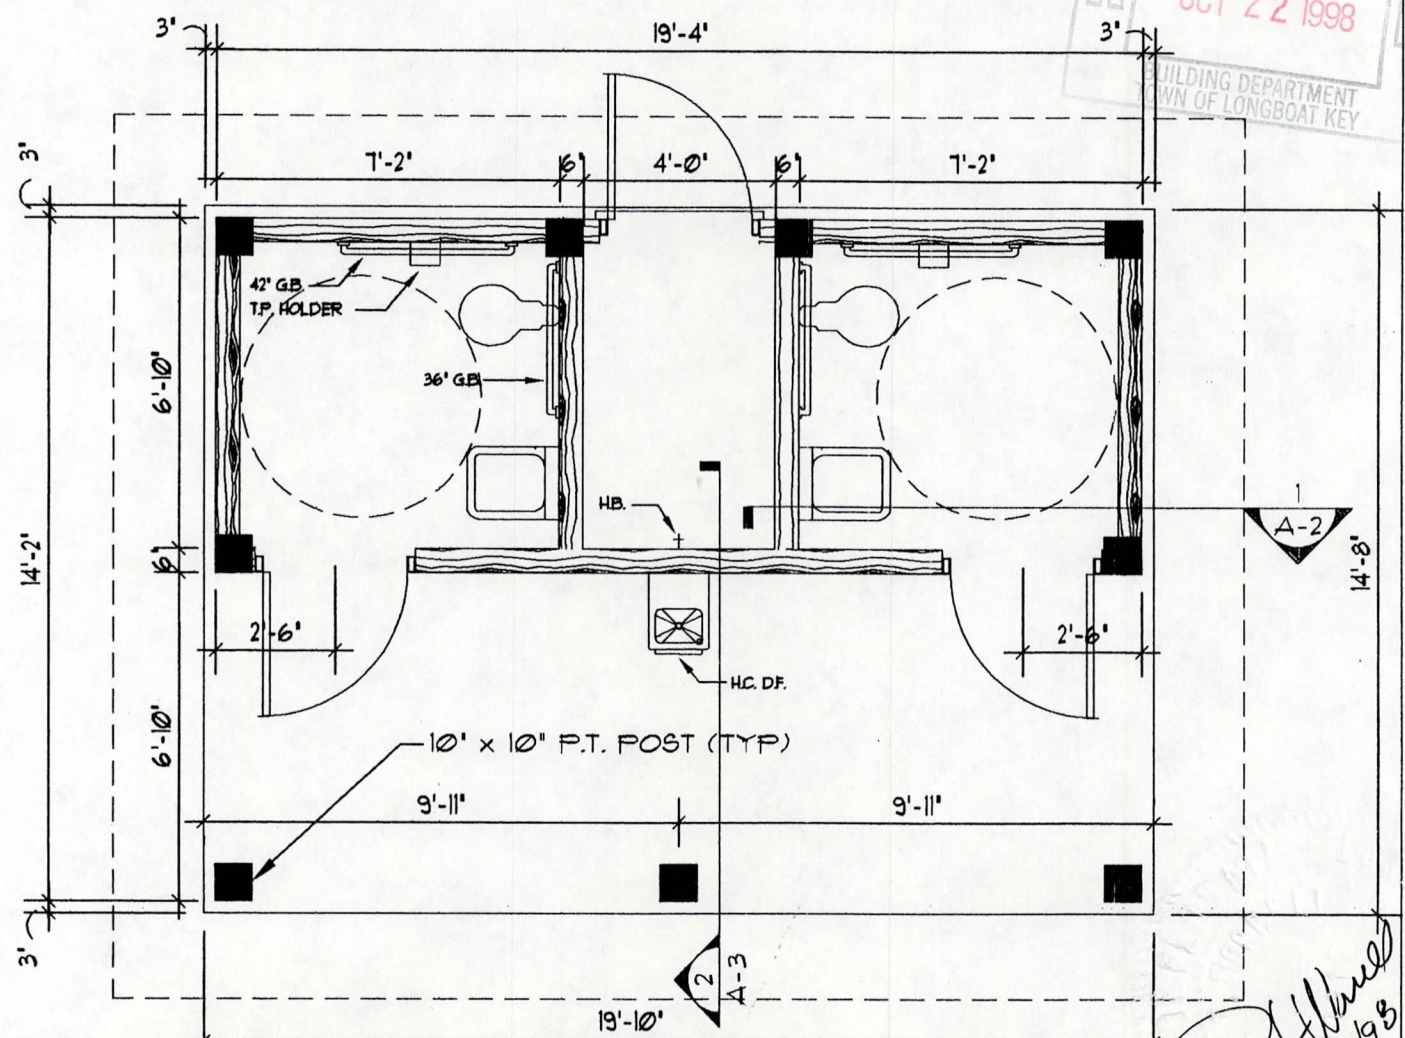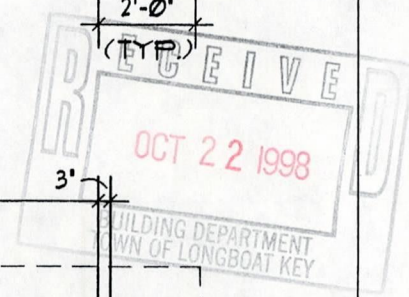


NOTES:
 1. PLUMBING FIXTURES BY OWNER

FLOOR PLAN

SCALE: 1/4" = 1'-0"

[Handwritten signature]
 10/22/98

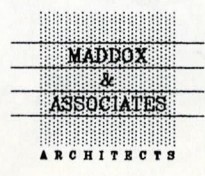

JOAN M. DURANTE PARK
 RESTROOM BUILDING


PROJECT NO.	9301204	.	.
DATE	5/12/98	.	.
DRAWN BY:	WET	.	.
CHECKED BY:	WET	.	.
SCALE:	1/4" = 1'-0"	.	.
SHEET NO.		.	.

A-1

1 * 6/1/98 * HC CIRCLE
 NO. DATE REVISION

NOTE: THIS STRUCTURE HAS BEEN DESIGNED TO WITHSTAND 110 MPH WIND LOADS AS REQUIRED BY STANDARD BUILDING CODE

FILE COPY

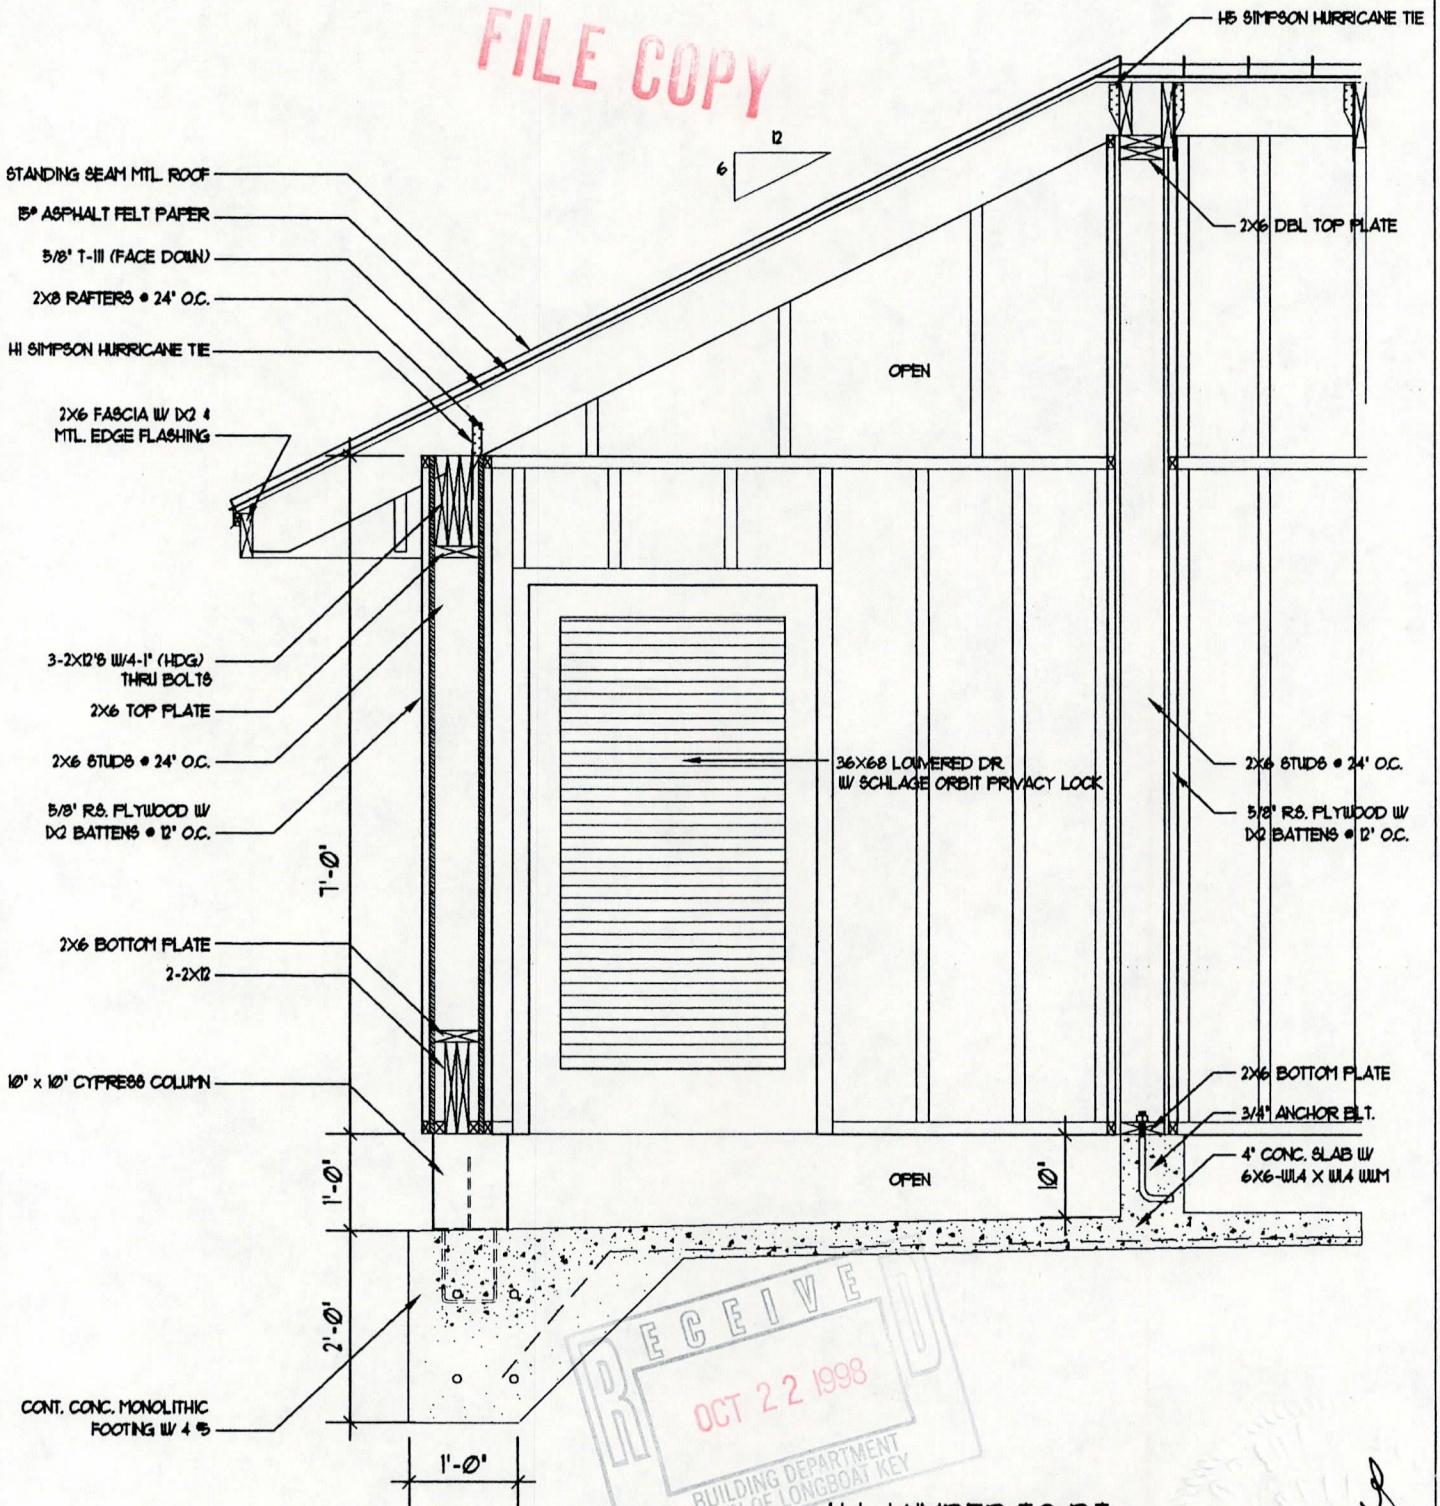

SECTION 1

SCALE: 1/2" = 1'-0"

RECEIVED
OCT 22 1998
BUILDING DEPARTMENT
TOWN OF LONGBOAT KEY

ALL LUMBER TO P.T.


Handwritten signature and date:
10/22/98

MADDOX & ASSOCIATES ARCHITECTS

JOAN M. DURANTE PARK
RESTROOM BUILDING

PROJECT NO.	9301204	
DATE	5/12/98	
DRAWN BY	WEM1	
CHECKED BY	WEM1	
SCALE	1/4" = 1'-0"	
SHEET NO.		
A-2		
NO.	DATE	REVISION

FILE COPY

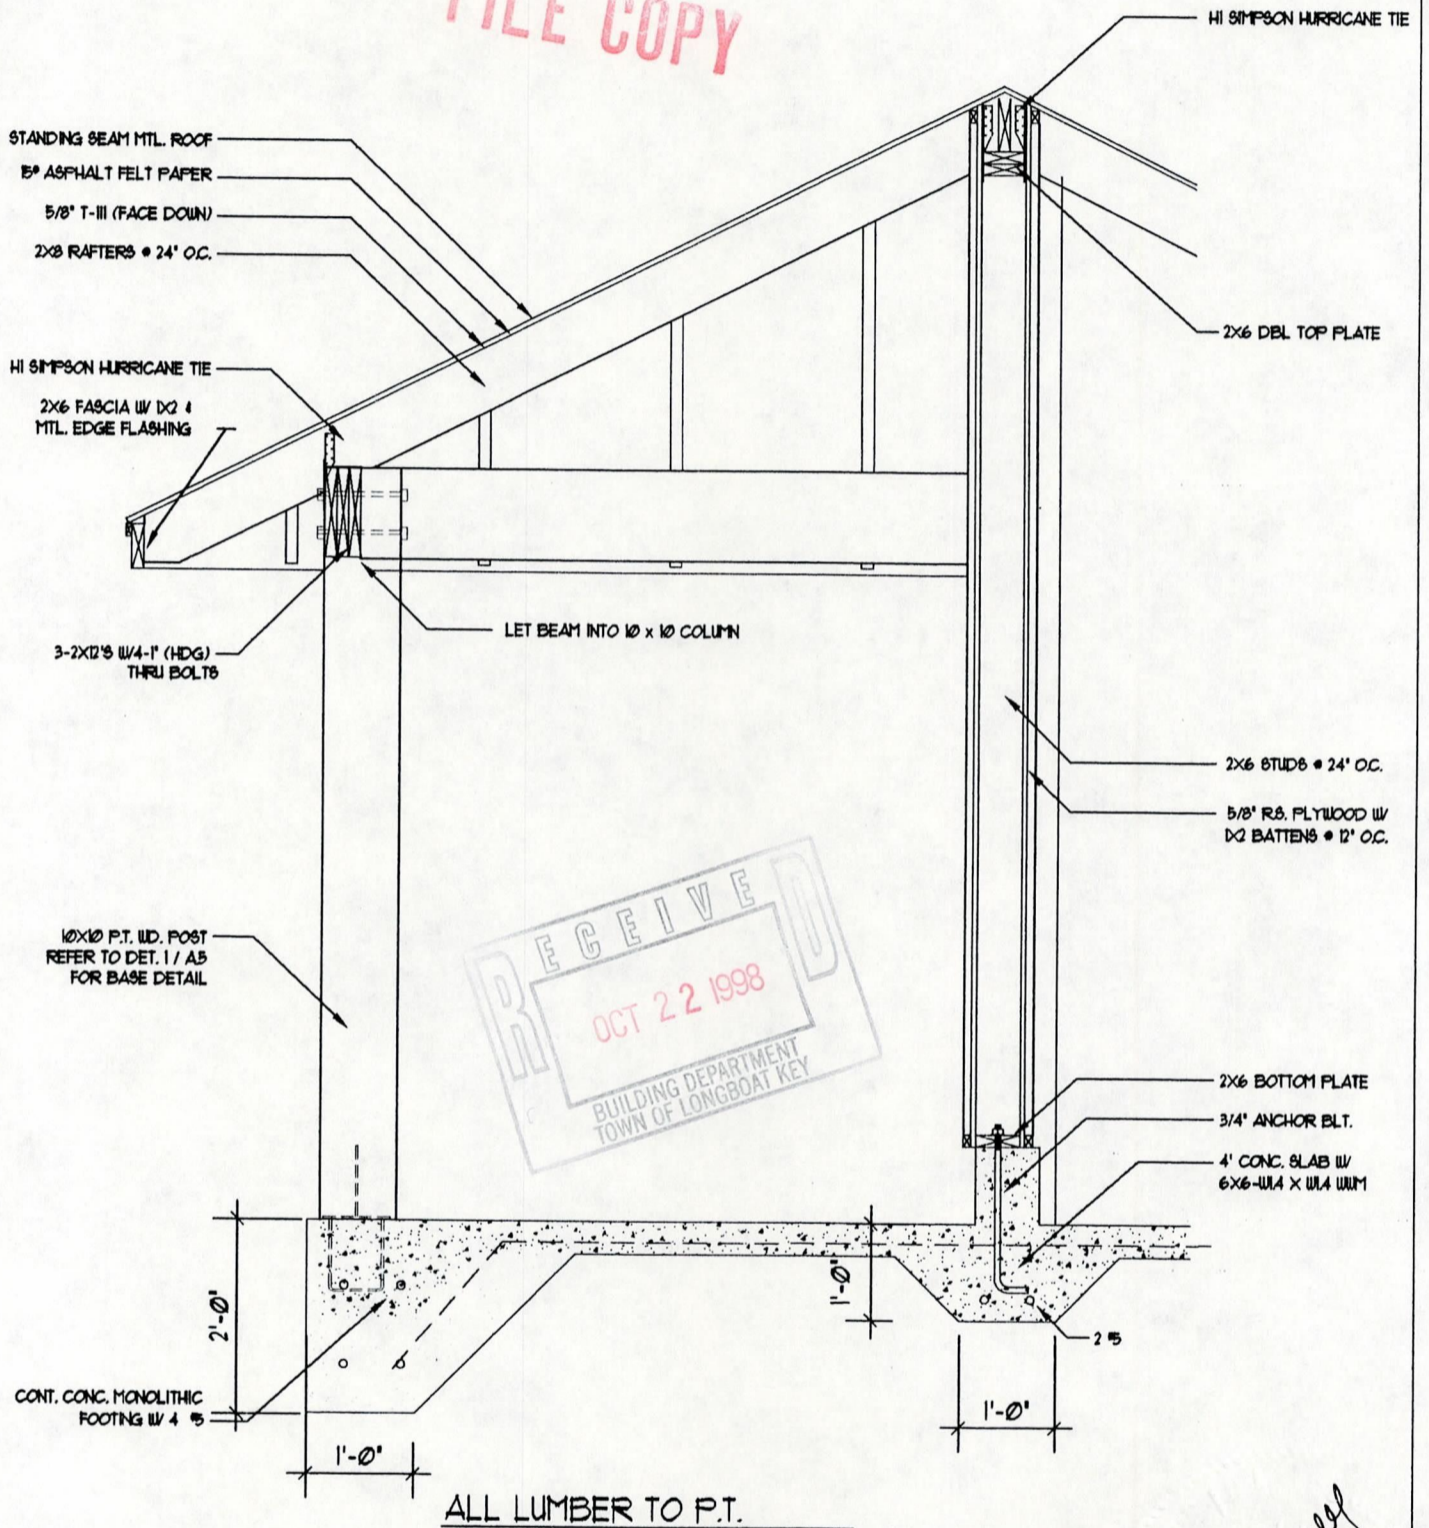

RECEIVED
 OCT 22 1998
 BUILDING DEPARTMENT
 TOWN OF LONGBOAT KEY


Handwritten signature and date:
 10/22/98

SECTION 2
 SCALE: 1/2" = 1'-0"

MADDOX
 &
 ASSOCIATES
 ARCHITECTS



JOAN M. DURANTE PARK
 RESTROOM BUILDING

PROJECT NO.	93012.04	.	.
DATE	5/12/98	.	.
DRAWN BY:	WEM	.	.
CHECKED BY:	WEM	.	.
SCALE:		.	.
SHEET NO.		.	.
	A-3	.	.
		NO. DATE REVISION	

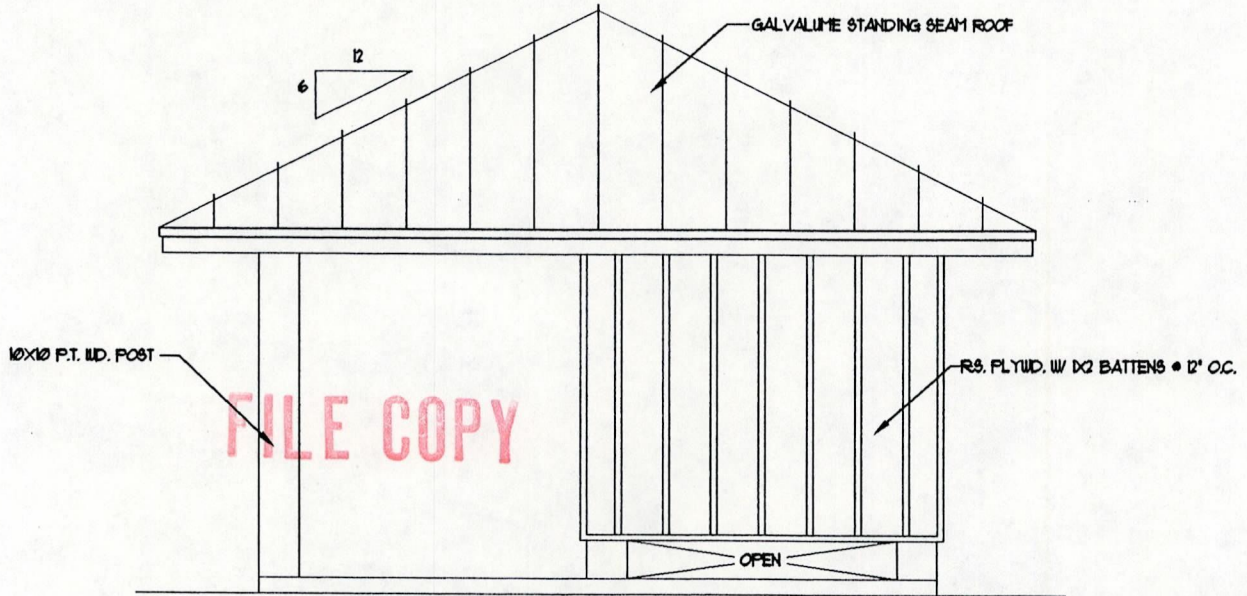

RIGHT ELEVATION

SCALE: 1/4"=1'-0"

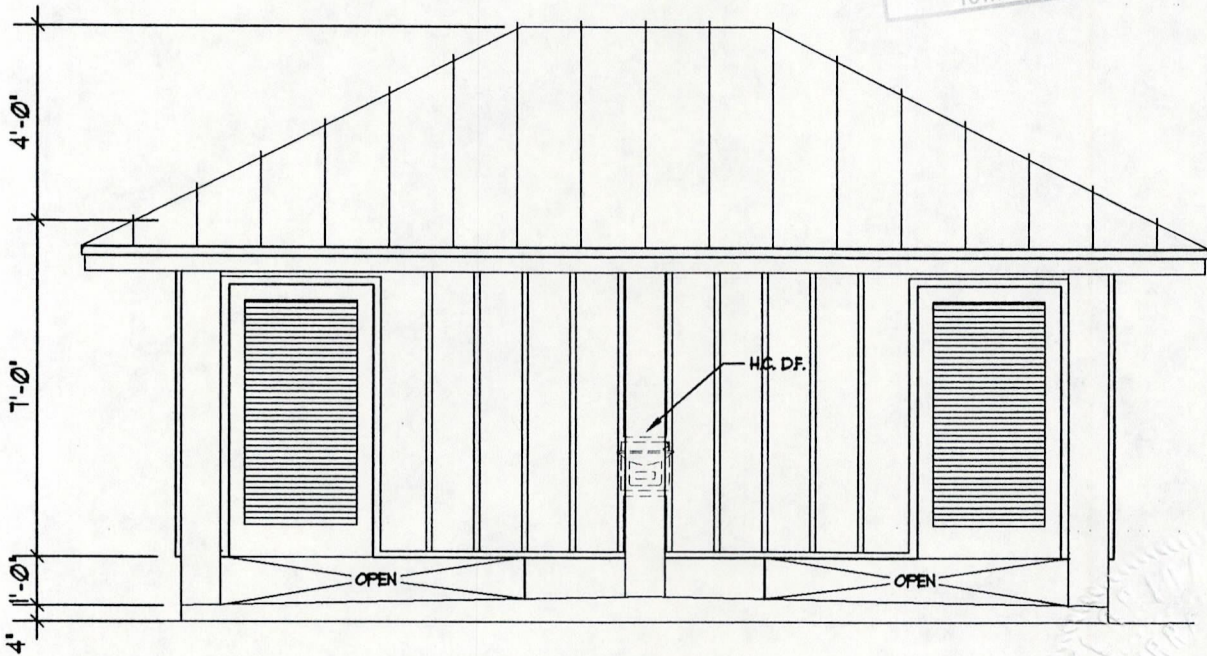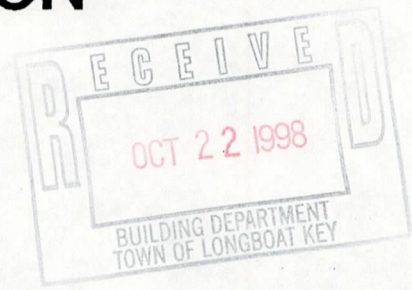


FRONT ELEVATION

SCALE: 1/4"=1'-0"

ALL LUMBER TO P.T.

Paul Harvey
10/22/98

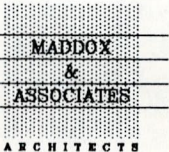


JOAN M. DURANTE PARK
RESTROOM BUILDING

PROJECT NO: 93012.04
DATE: 5/12/98
DRAWN BY: WEM
CHECKED BY: WEM
SCALE:
SHEET NO:

A-4

NO. DATE REVISION

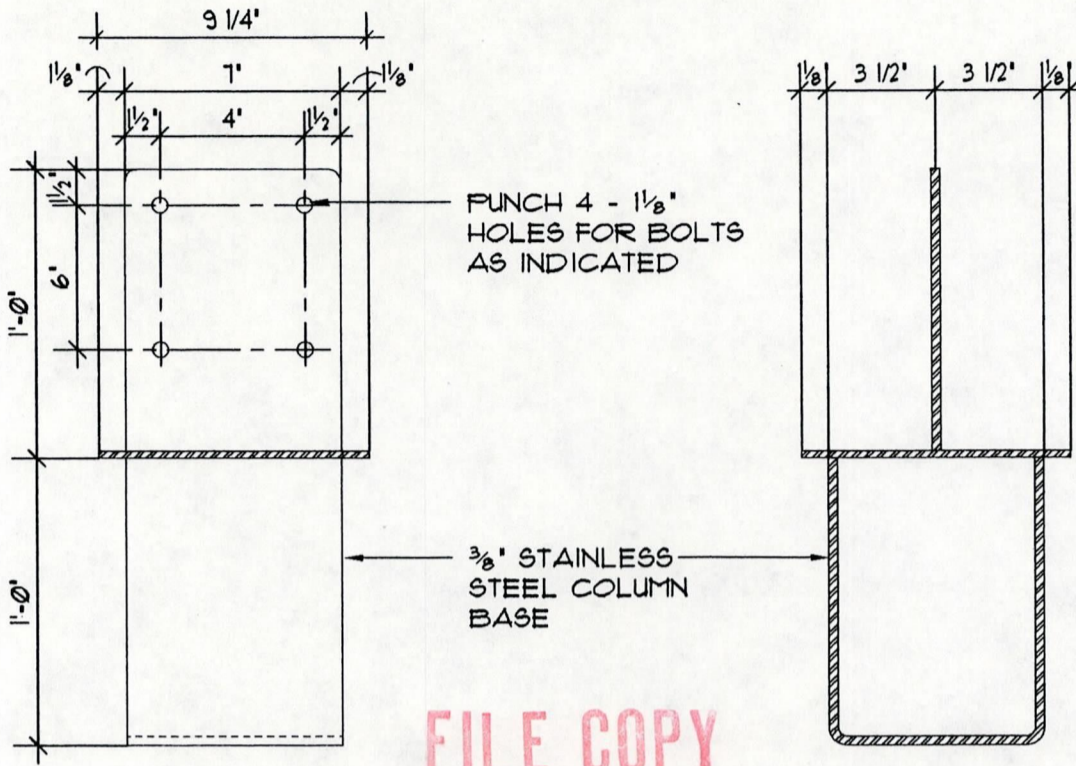

COL. BASE DETAIL

1
A-5

SCALE: 1/2" = 1'-0"

RECEIVED
OCT 22 1998
BUILDING DEPARTMENT
TOWN OF LONGBOAT KEY

Fred H. Hance
10/22/98

MADDOX
&
ASSOCIATES
ARCHITECTS

JOAN M. DURANTE PARK
RESTROOM BUILDING

PROJECT NO.: 93012.04
DATE: 5/12/98
DRAWN BY: GJM
CHECKED BY: WEM
SCALE:
SHEET NO.:

A-5

NO. DATE REVISION