

RENOVATION / REMODEL

CHERRY'S UNIT

SCOPE OF WORK

- CHANGE VANITIES.
- TUB INTO SHOWER IN BATH 2.
- REPLACE SHOWER IN GUEST BATH.
- INSTALL NEW EXHAUST FANS IN BATHROOMS.
- REPLACE LED CEILING CANS IN BATHROOMS.
- LIT MIRRORS ON A SWITCH FOR EACH BATHROOM.

CODE COMPLIANCE STATEMENT

1. BUILDING CODE :FLORIDA BUILDING CODE RESIDENTIAL, 2023 - 8TH EDITION
2. MECHANICAL CODE : FLORIDA BUILDING CODE, MECHANICAL 2023 - 8TH EDITION
3. PLUMBING CODE :FLORIDA BUILDING CODE, PLUMBING 2023 - 8TH EDITION
4. FIRE CODE :FLORIDA FIRE PREVENTION CODE 2023 - 8H EDITION
5. ELECTRICAL CODE :NFPA 70, NEC 2020
6. LIFE SAFETY CODE :NFPA 101 2018 EDITION
7. ACCESSIBILITY :FLORIDA BUILDING CODE, BUILDING 2023 - 8H EDITION
8. ENERGY CODE :FLORIDA BUILDING CODE, BUILDING 2023 - 8TH EDITION

MECHANICAL, ELECTRICAL,
AND PLUMBING REVIEWS
WILL BE DEFERRED TO
FIELD INSPECTORS

Permit # 24-0255
REVIEWED FOR CODE COMPLIANCE
LONGBOAT KEY BUILDING DEPT.

APR 29 2024

APPROVED
Reviewer: *Jonathan*

RECEIVED

APR 25 2024
TOWN OF LONGBOAT KEY
Planning, Zoning & Building

RENOVATION SRQ
KYLE CICCETTI
5532 SUMMIT GLEN, BRADENTON
FLORIDA 34203
Lic. 1254055 Phone: 941-812-7065

REV.	DATE	DESCRIPTION
1	4-24-24	REVISION 1
2		
3		

RENOVATION / REMODEL
CHERRY'S

BLDG PERMIT PLANS
FILE
Copy of Record


DATE:

3-15-24


SCALE:

SHEET:

A1.0

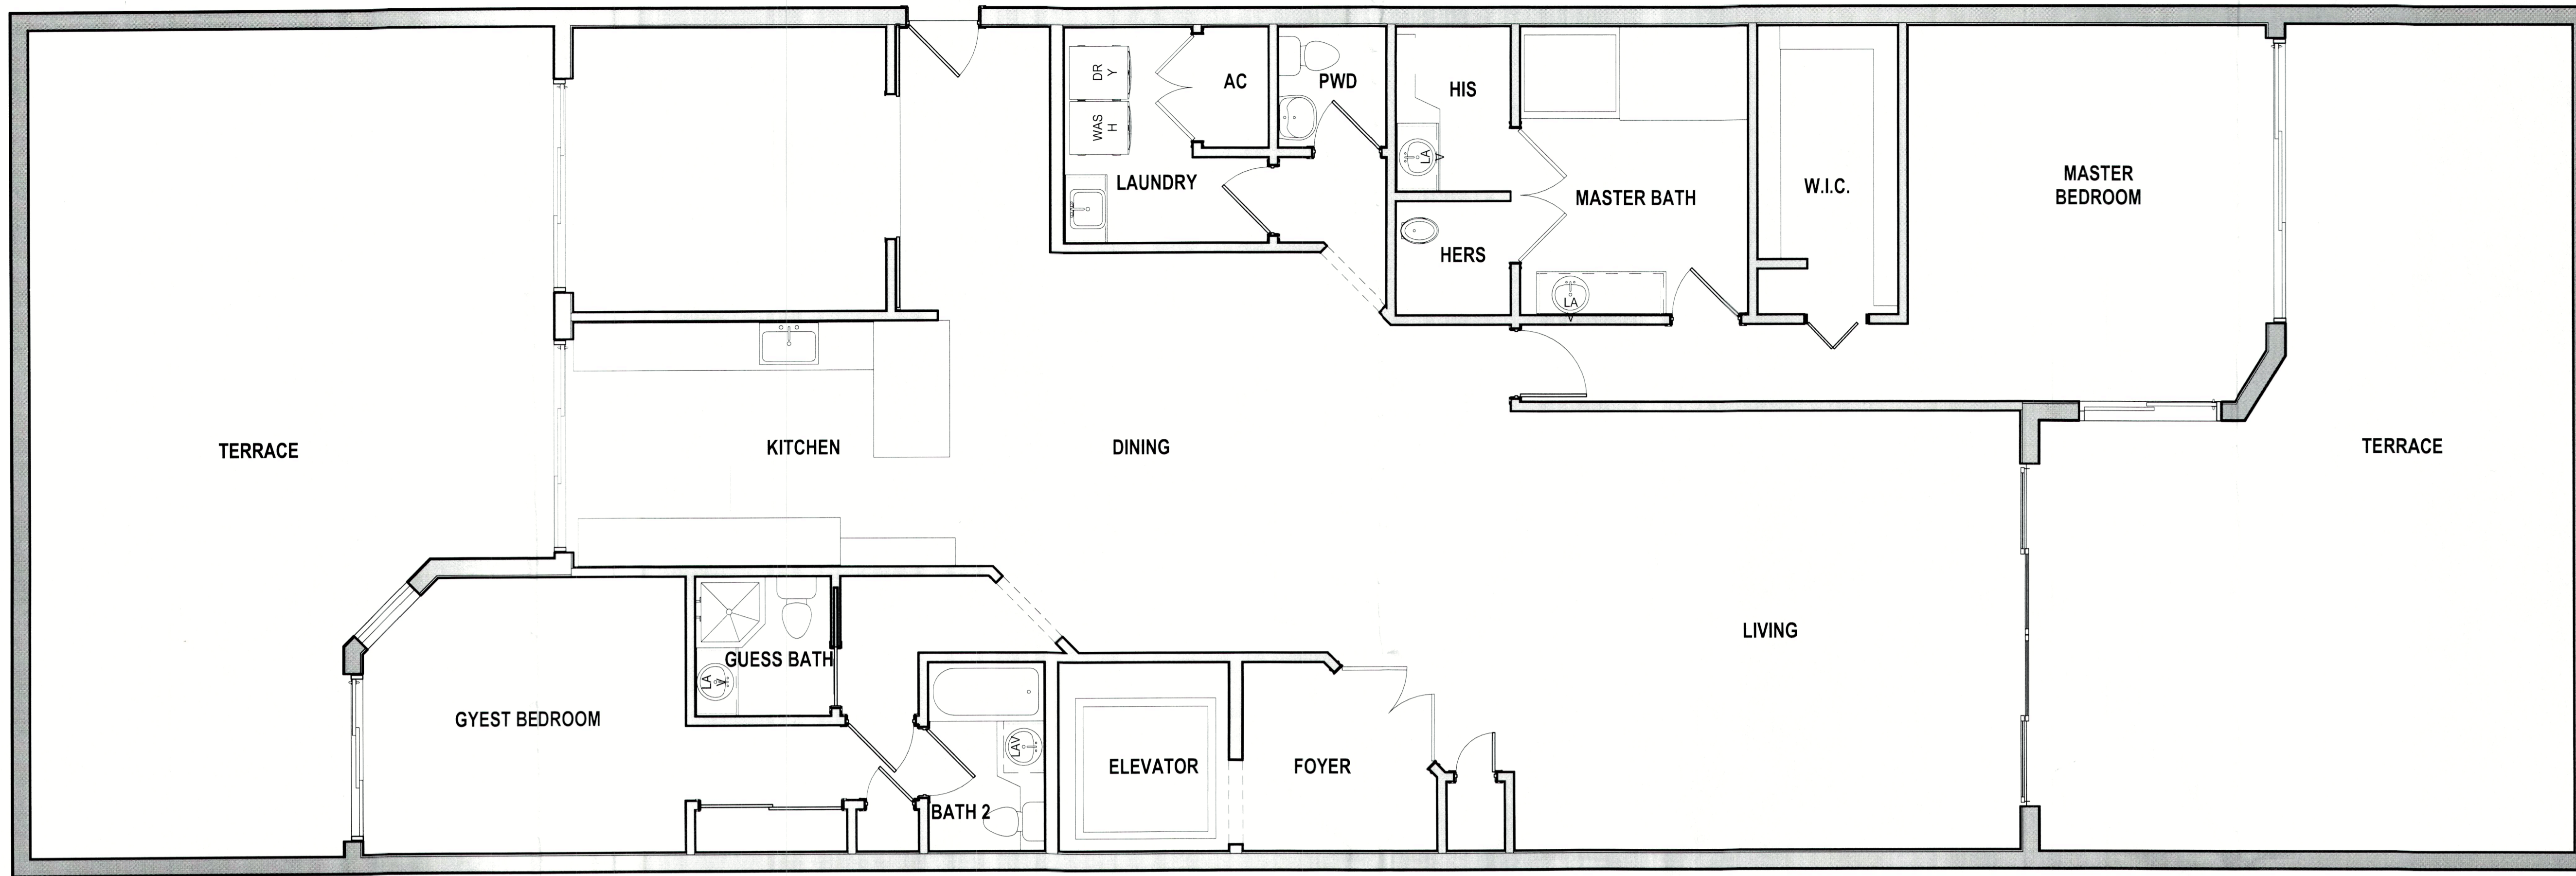

6 EXISTING FLOOR PLAN
1/4" = 1'-0"

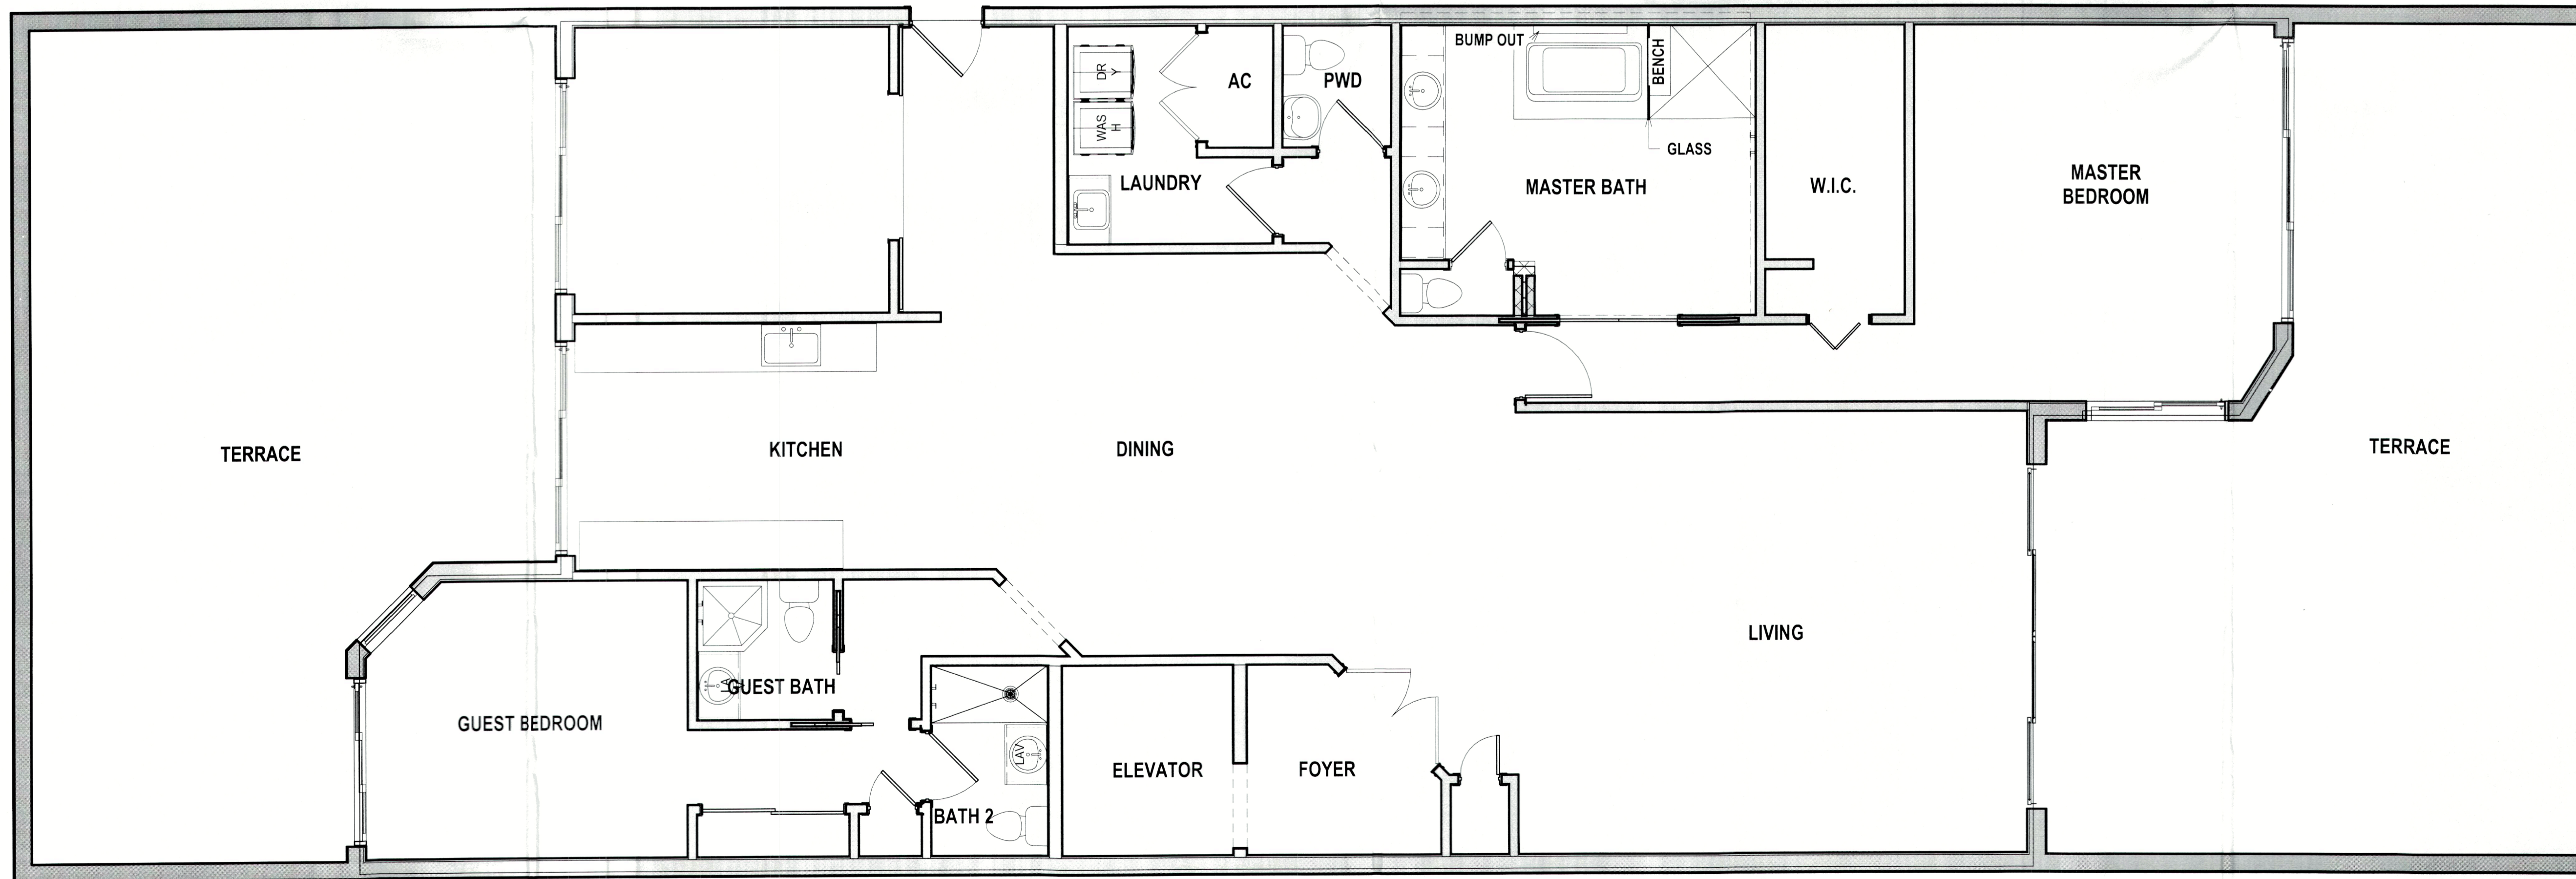

1 PROPOSED FLOOR PLAN
1/4" = 1'-0"

RENOVATION SRQ
 KYLE CICCCHETTI
 5532 SUMMIT GLEN, BRADENTON
 FLORIDA 34203
 Lic. 1254055 Phone: 941-812-7065

REV	DATE	DESCRIPTION
1	4-24-24	REVISION 1
2		
3		

RENOVATION / REMODEL
 CHERRY'S

BLDG PERMIT PLANS
 FILE
 Copy of Record

DATE:


3-15-24

SCALE:

SHEET:

A2.0

RECEIVED
 APR 25 2024
 TOWN OF LONGBOAT KEY
 Planning, Zoning & Building

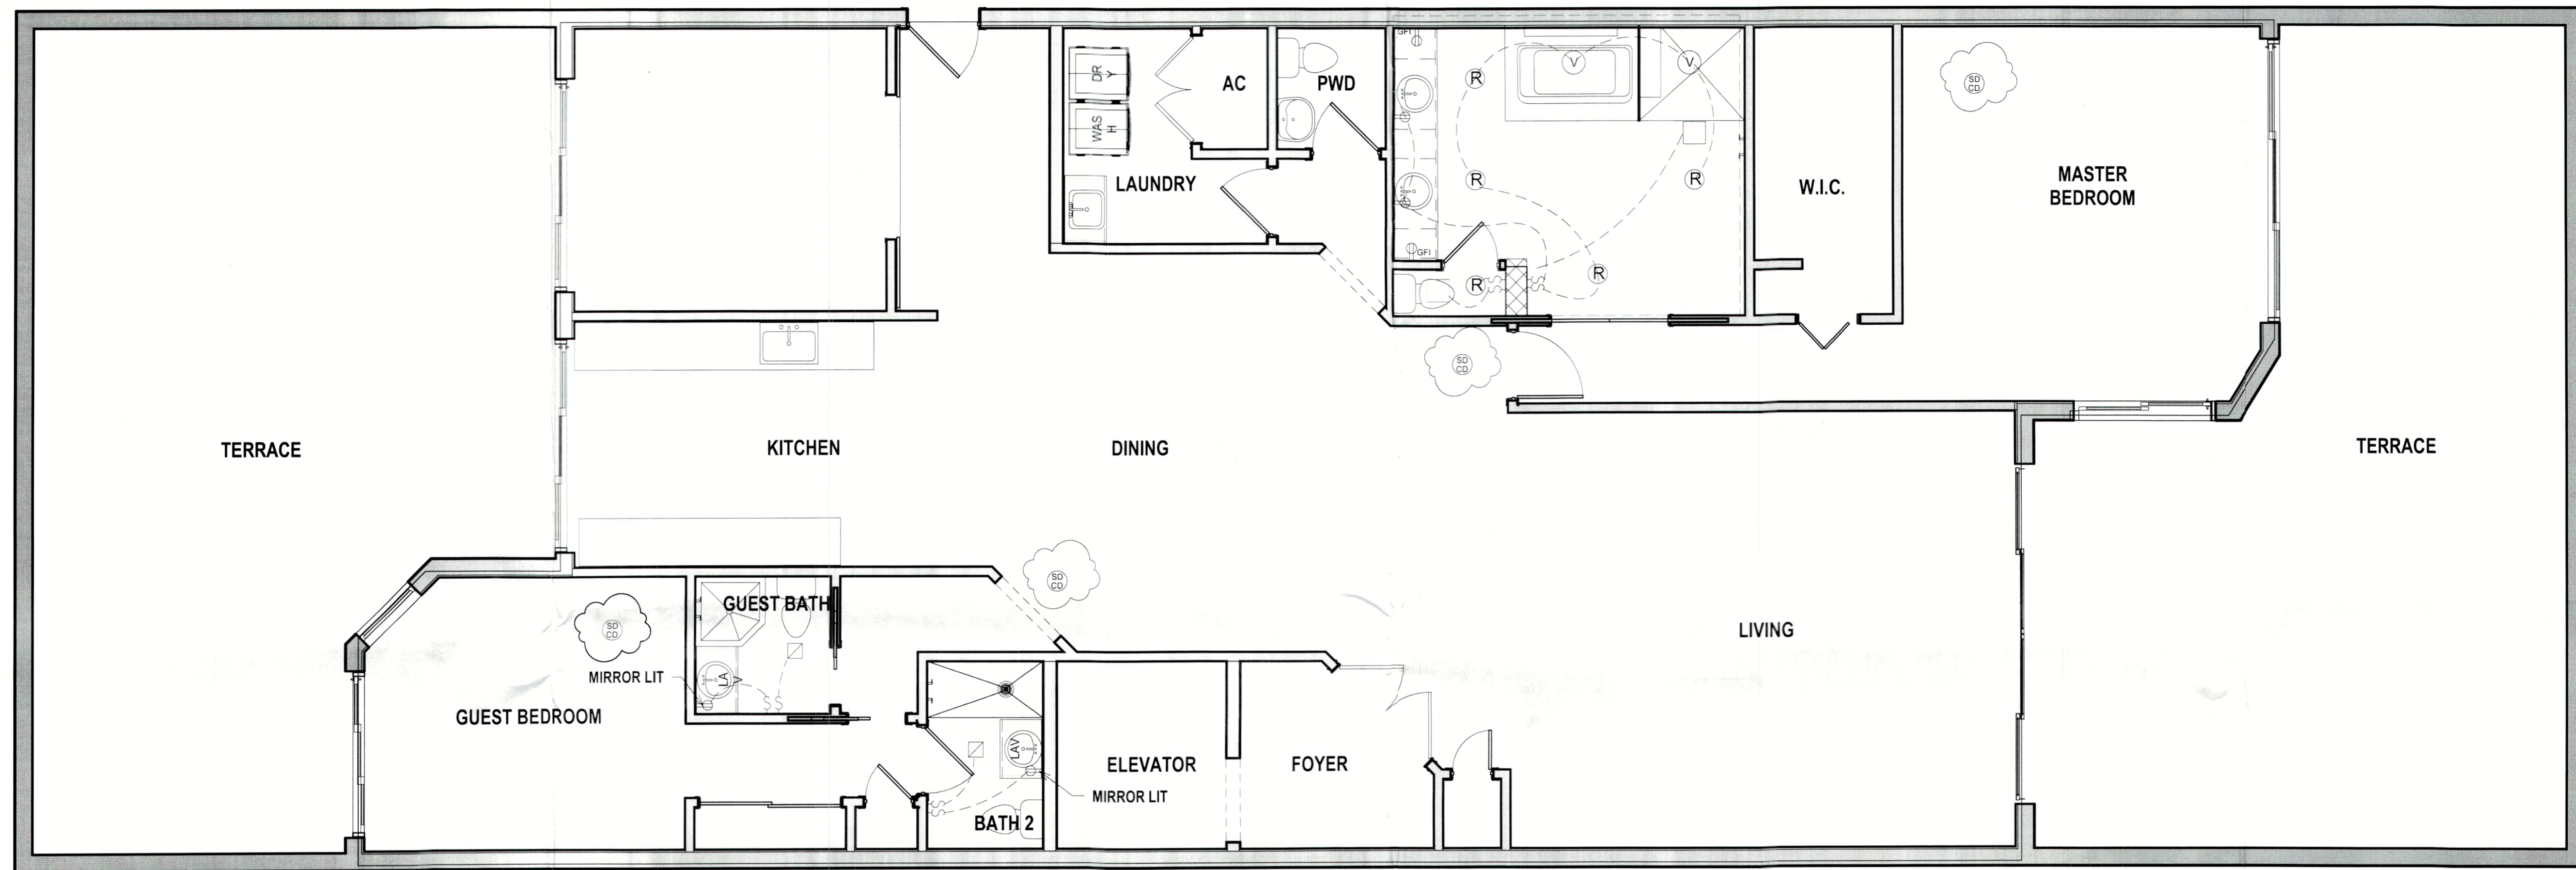

1 PROPOSED ELECTRICAL FLOOR PLAN
1/4" = 1'-0"

- ELECTRICAL SYMBOLS:**
- ⊕ DUPLEX OUTLET
 - ⊖ DUPLEX OUTLET HALF
 - ⊕ GFI DUPLEX OUTLET W/ GROUND FAULT INDICATOR UNDER CABINET OUTLET
 - S SINGLE SWITCH
 - S₃ THREE-WAY SWITCH
 - ⊠ EXHAUST FAN
 - Ⓡ RECESSED LED FIXTURE
 - Ⓥ RECESSED LED VAPOR PROOF FIXTURE
 - Ⓢ SEALED LED RETRO CAN
 - Ⓢ Ⓢ SMOKE DETECTOR, HARD WIRED, INTERCONNECTED

RENOVATION SRQ
 KYLE CICCCHETTI
 5532 SUMMIT GLEN, BRADENTON
 FLORIDA 34203
 Lic. 1254055 Phone: 941-812-7065

REV.	DATE	DESCRIPTION
1	4-24-24	REVISION 1
2		
3		

RENOVATION / REMODEL
 CHERRY'S

BLDG PERMIT PLANS
 FILE
 Copy of Record

DATE:
3-15-24

SCALE:

SHEET:

A3.0

RECEIVED
 APR 2 5 2024
 TOWN OF LONGBOAT KEY
 Planning, Zoning & Building